


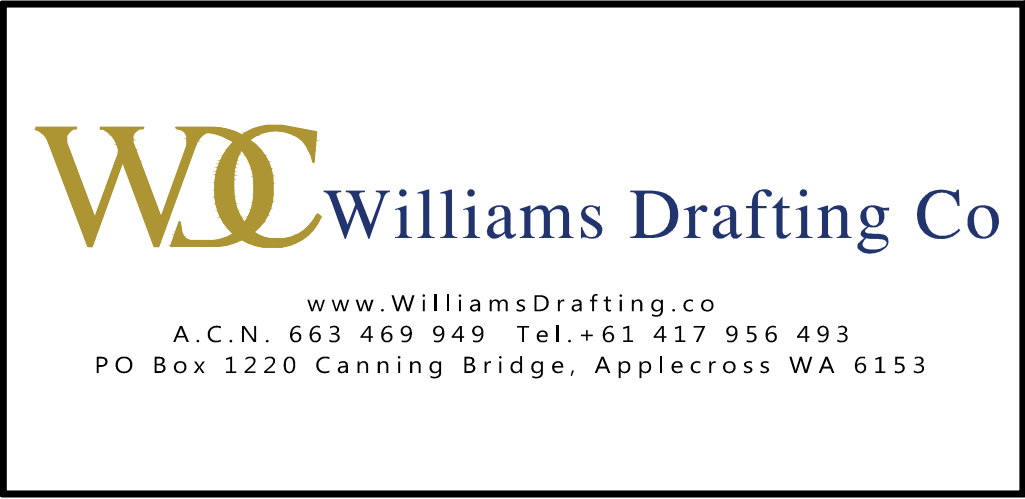

PROPOSED CATTERY
5B KELLY COURT
SPRINGVALE, VICTORIA

WDC JOB NUMBER:

WDC24-0036

DRAWING SCHEDULE:


DRG#	REV#	DESCRIPTION
WDC24-0036 A1	0	GENERAL NOTES
WDC24-0036 A2	0	FLOOR PLAN
WDC24-0036 A3	0	ROOF PLAN
WDC24-0036 A4	0	ELEVATIONS & SECTIONS
WDC24-0036 A5	0	PLUMBING PLAN
WDC24-0036 A6	0	ELECTRICAL PLAN
WDC24-0036 A7	0	FIRE PLAN

NOTES:

1. ALL DRAWINGS ARE ISSUED UPON FIRST RELEASE AS REVISION 'A'. SUBSEQUENT DRAWING RELEASES UP TO 'ISSUED FOR CONSTRUCTION' DRAWINGS ARE ASSIGNED ASCENDING LETTERS (B, C, D...).
2. 'ISSUED FOR CONSTRUCTION' DRAWINGS ARE ISSUED AS REVISION '0' (ZERO). SUBSEQUENT REVISIONS ARE ASSIGNED ASCENDING NUMBERS (1, 2, 3...).
3. SHOULD ANY DISCREPANCIES OCCUR BETWEEN THE DRAWING SCHEDULE & ACTUAL DRAWING SET RECEIVED, PLEASE CONTACT WDC IMMEDIATELY FOR CONFIRMATION THAT YOU ARE IN POSSESSION OF THE MOST CURRENT SET.


This document has been copied and made available for the purpose of the planning process as set out in the Planning and Environment Act 1987. The information must not be used for any other purpose. By taking a copy of this document you acknowledge and agree that you will only use the document for the purpose specified above and that any dissemination, distribution or copying of this document is strictly prohibited.

[illegible]

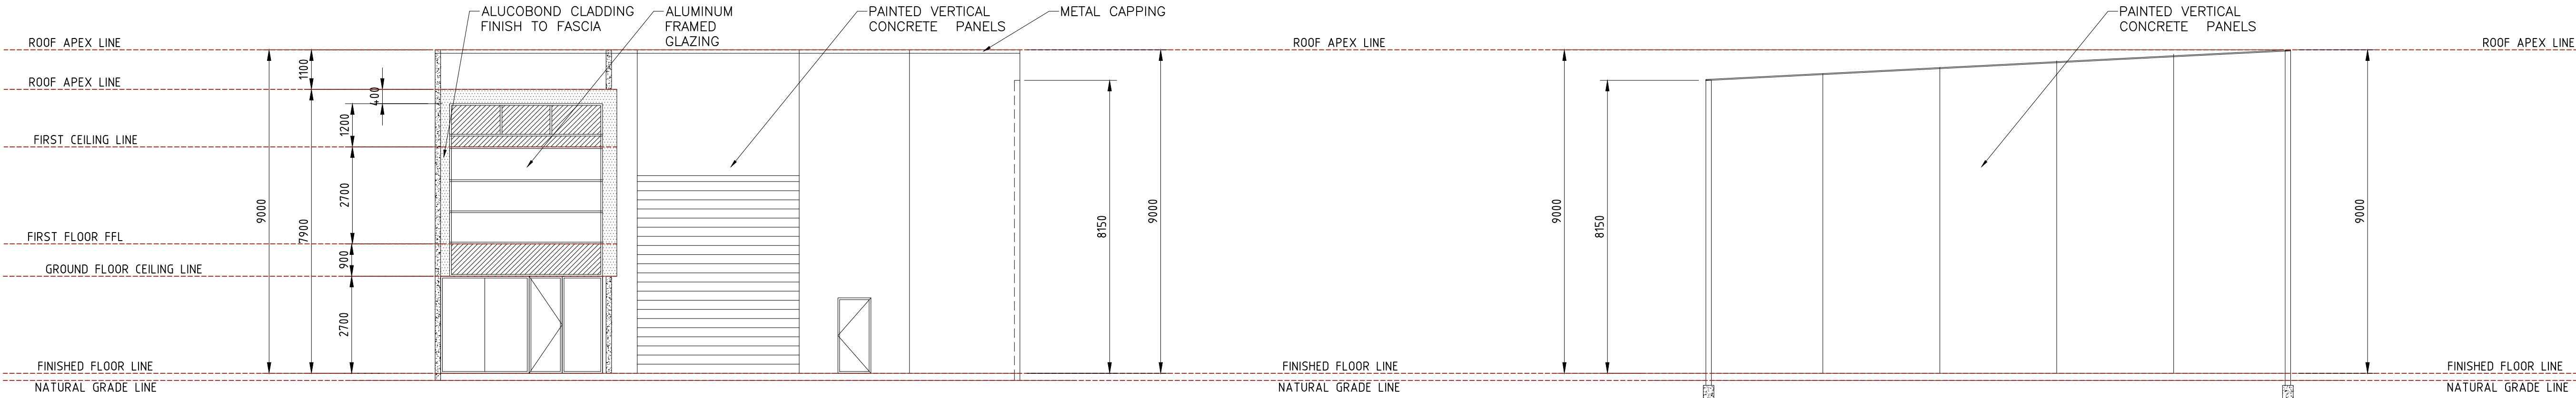


NORTHERN ELEVATION

SOUTHERN ELEVATION

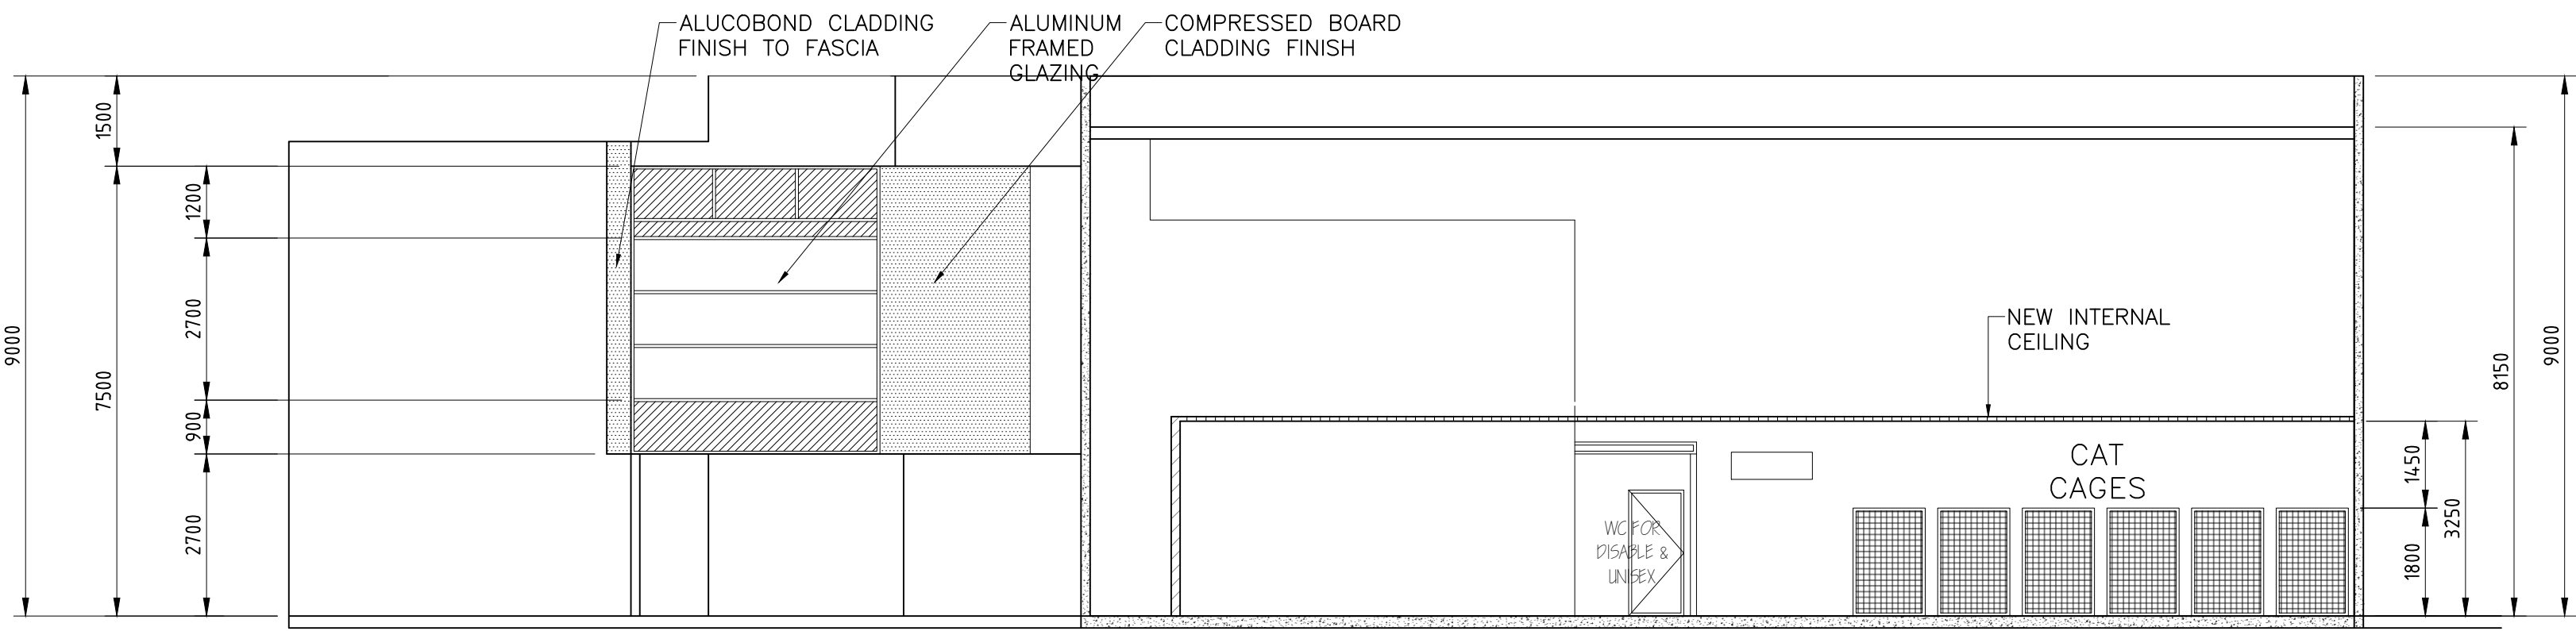

SECTION A-A


A
A2
1:100

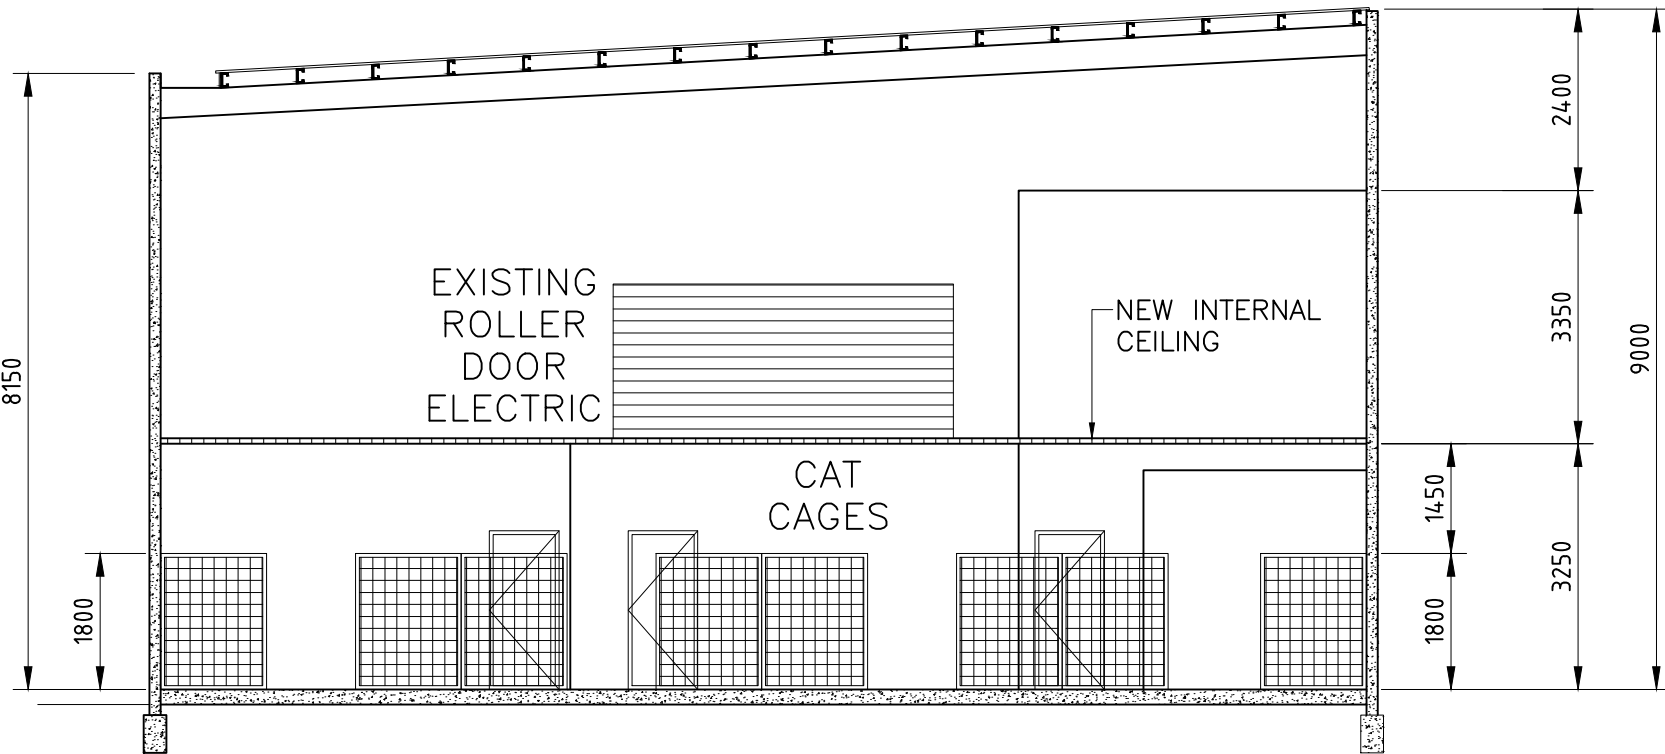

SECTION C-C

C
A2
1:100

This document has been copied and made available for the purpose of the planning process as set out in the Planning and Environment Act 1987. The information must not be used for any other purpose. By taking a copy of this document you acknowledge and agree that you will only use the document for the purpose specified above and that any dissemination, distribution or copying of this document is strictly prohibited.

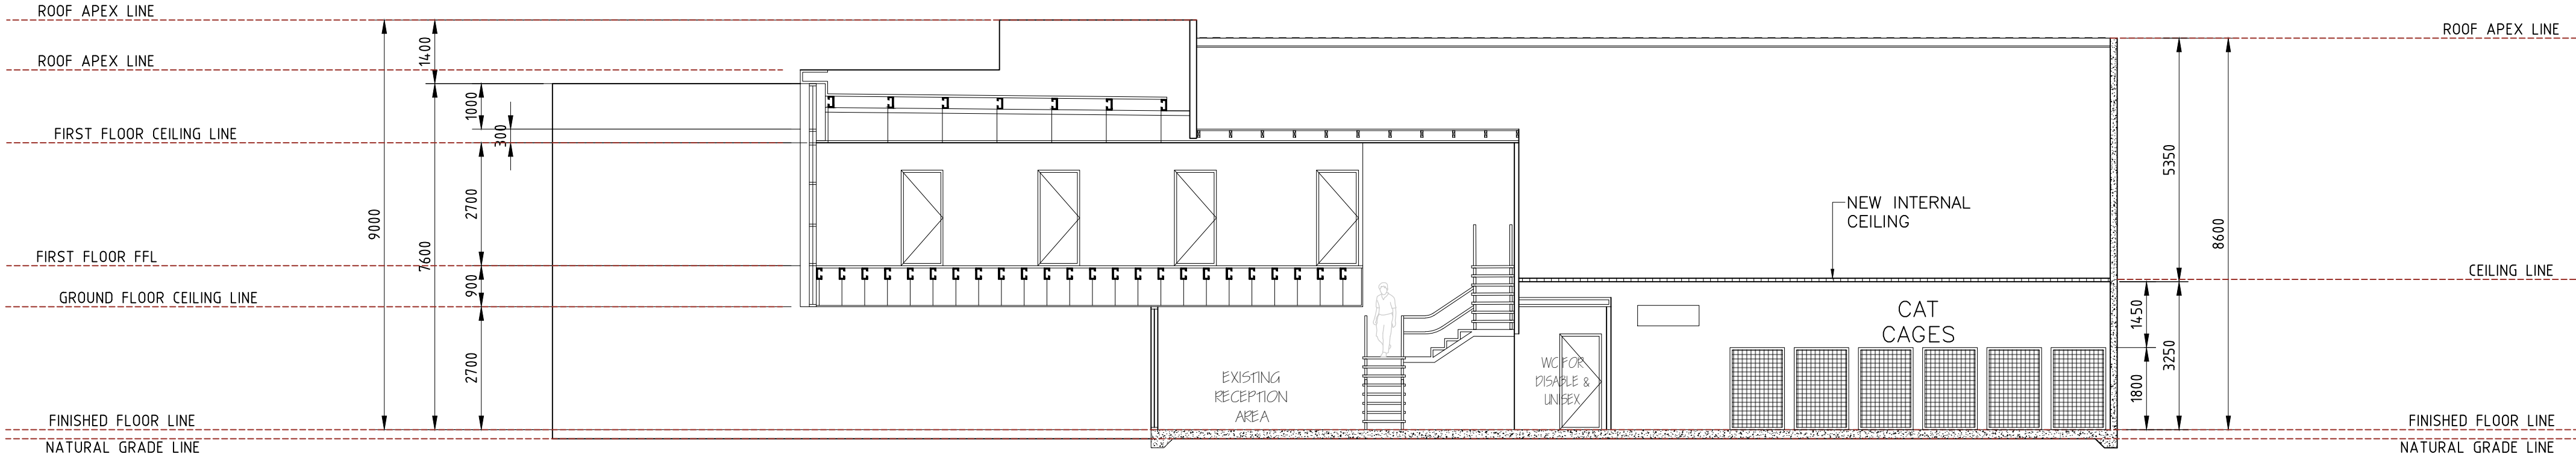

SECTION B-B


B
A2
1:100

LEGEND	
MARK	DESCRIPTION
	NEW INTERNAL WALL
	EXISTING CONCRETE WALL
	WET AREA SET DOWN
	EXISTING INTERNAL WALL
	NEW INTERNAL CEILING

DRAWING NOTES

PROJECT			
PROPOSED CATTERY			
5B KELLY COURT			
SPRINGVALE, VICTORIA			
SHEET			
ELEVATIONS & SECTIONS- SHEET 3			
DRAWN LJS SCALE (@ A1): 1:100			
DESIGNED	BW	WDC24-0036-A4	
CHECKED	BW	REV B	

This document has been copied and made available for the purpose of the planning process as set out in the Planning and Environment Act 1987. The information must not be used for any other purpose. By taking a copy of this document you acknowledge and agree that you will only use the document for the purpose specified above and that any dissemination, distribution or copying of this document is strictly prohibited.

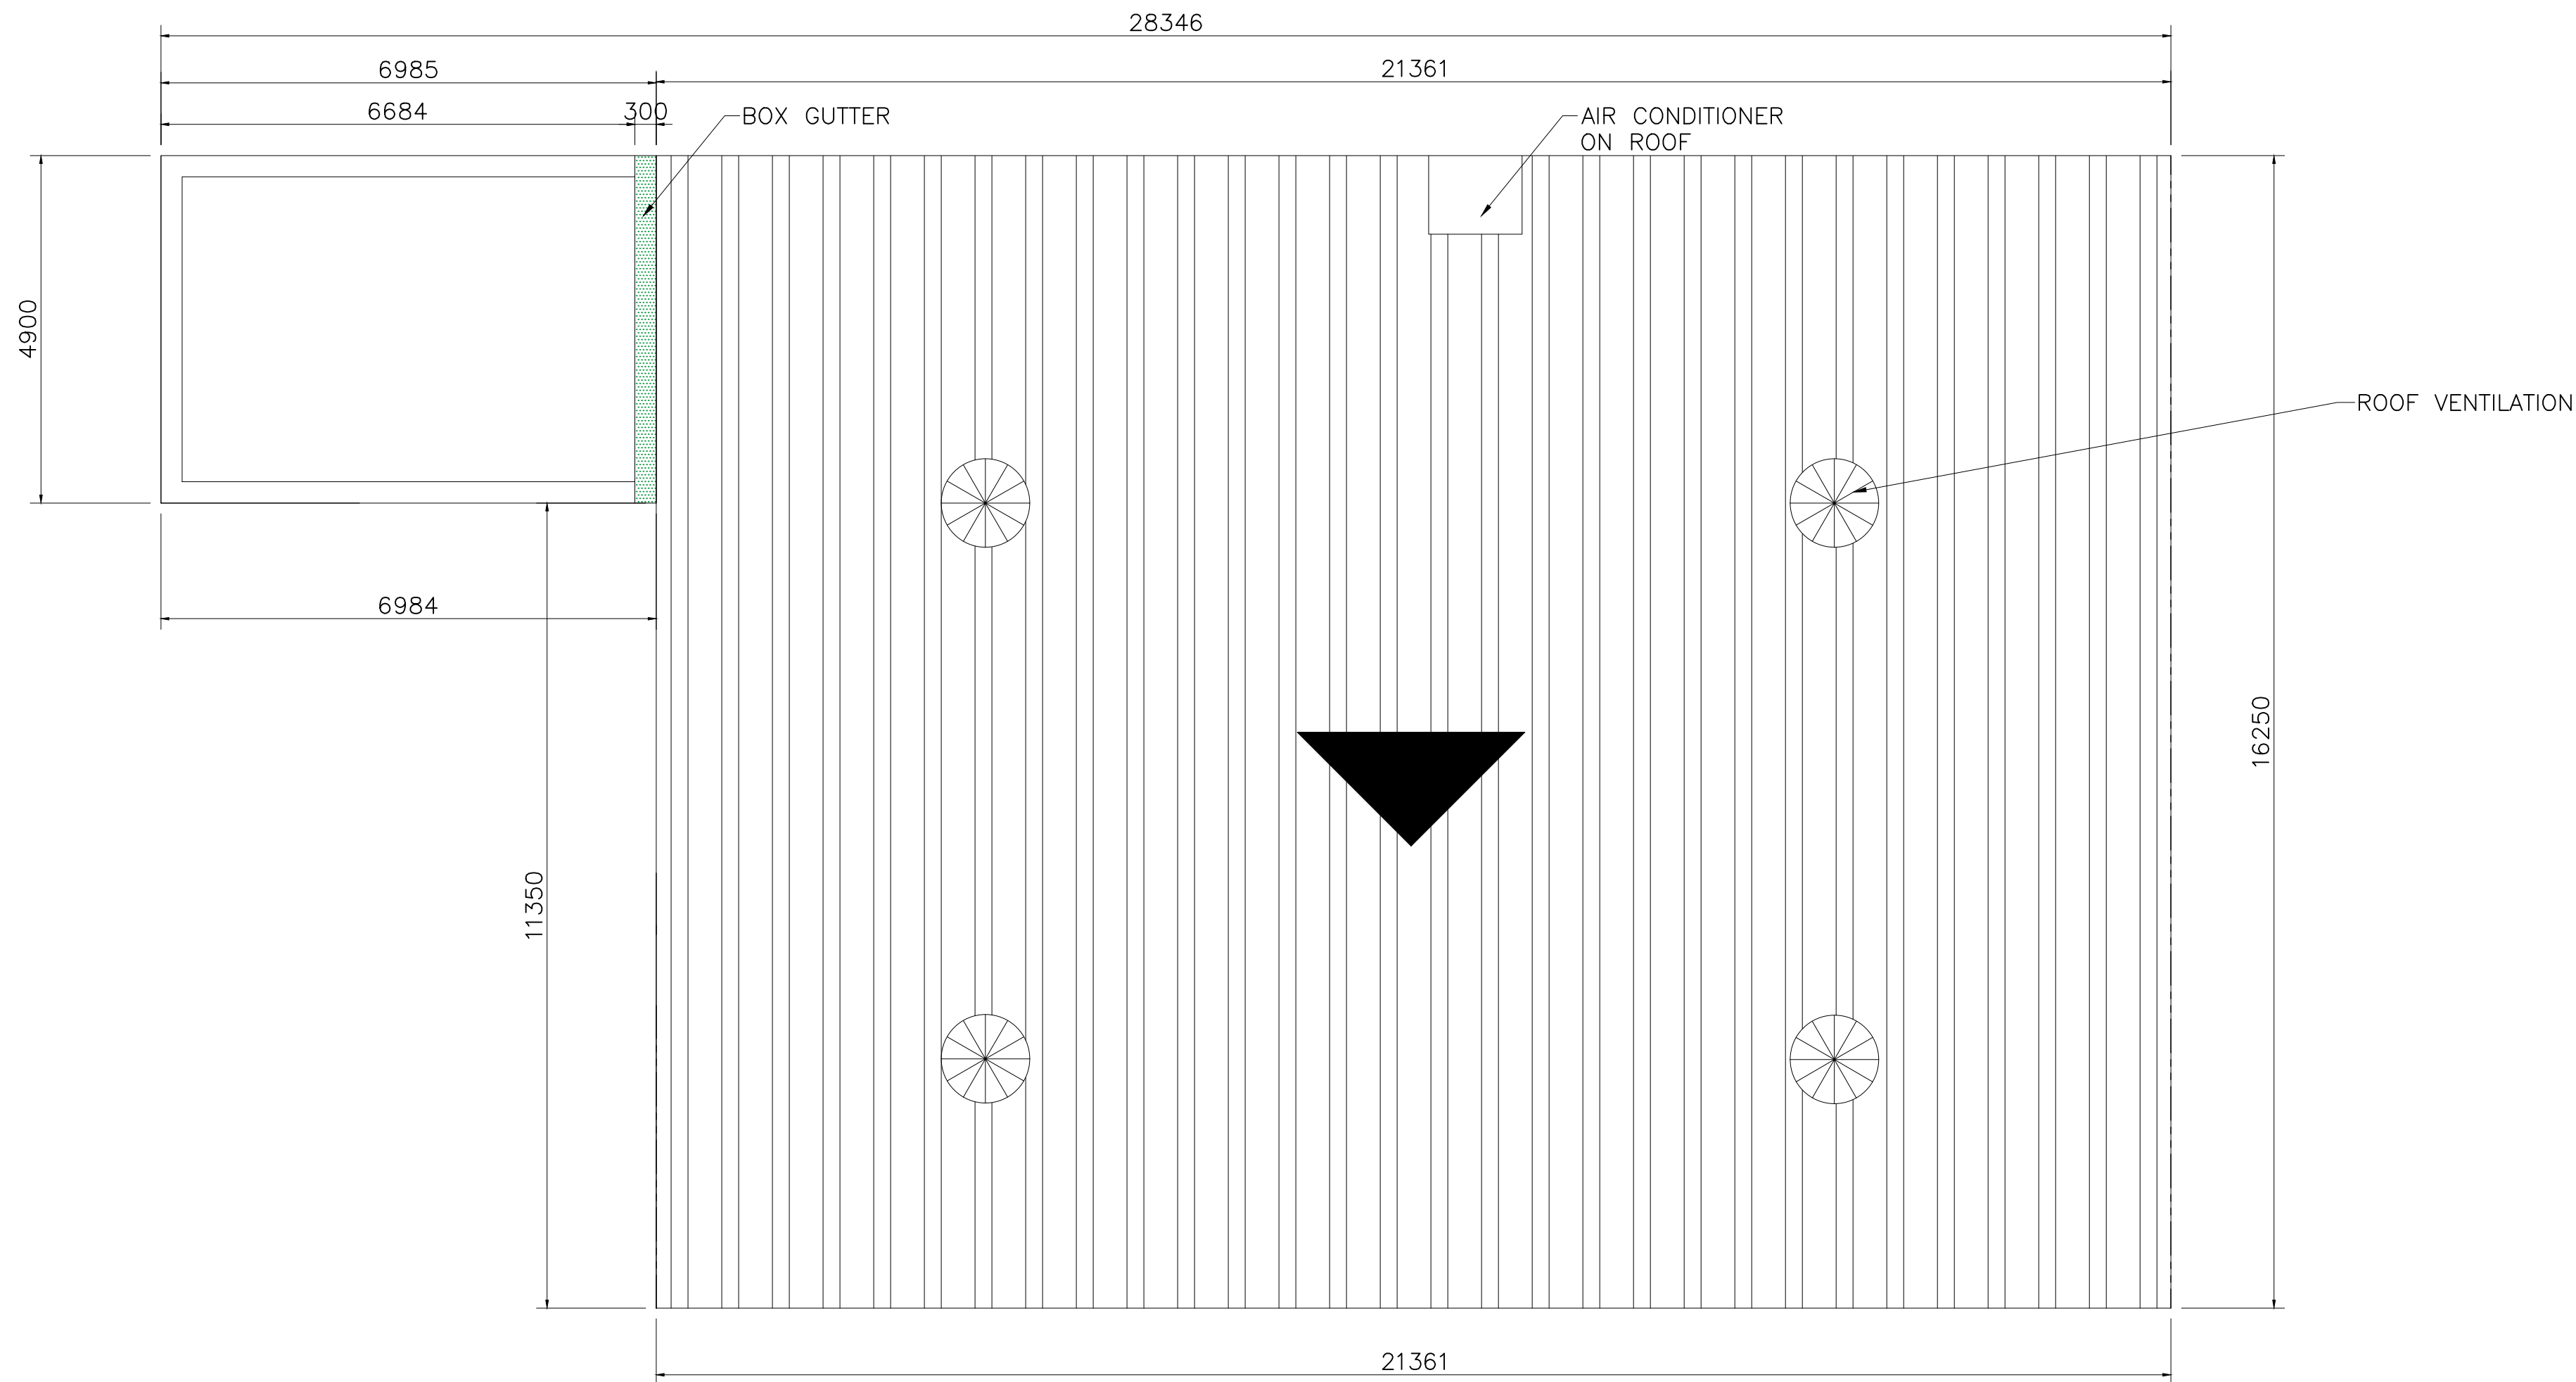

ROOF PLAN


SCALE 1:75

DRAWING NOTES

1. AIR CONDITIONING UNIT TO BE LOCATED AS PER CONVENIENT FOR INSTALLER.
2. ROOF VENTILATION TO BE INSTALLED AS PER SPECIALIST RECOMMENDATION.


[illegible]

This document has been copied and made available for the purpose of the planning process as set out in the Planning and Environment Act 1987. The information must not be used for any other purpose. By taking a copy of this document you acknowledge and agree that you will only use the document for the purpose specified above and that any dissemination, distribution or copying of this document is strictly prohibited.

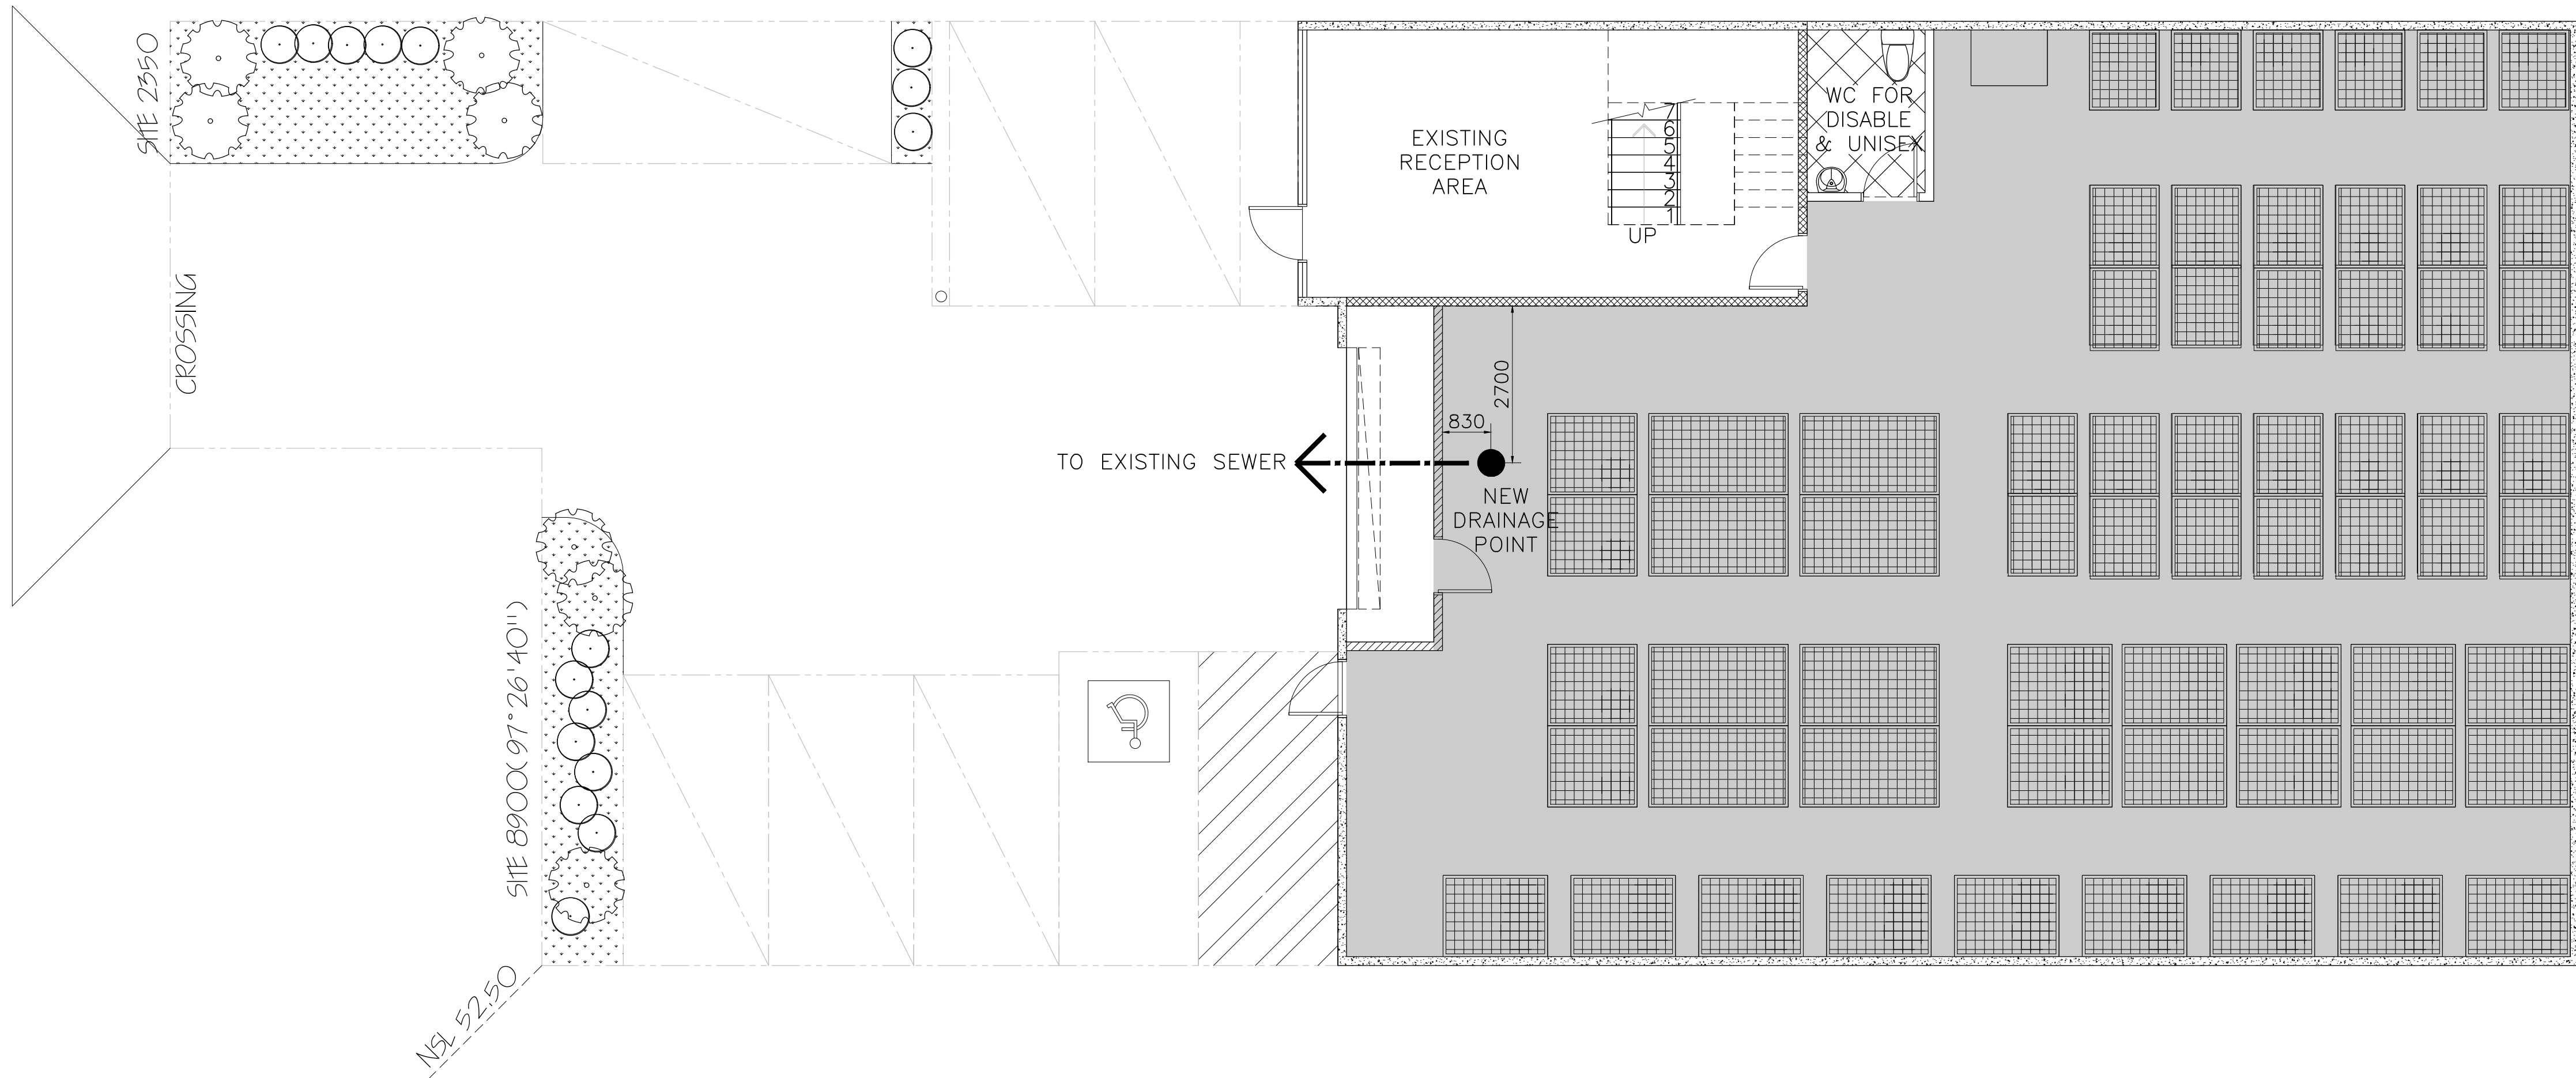

PLUMBING PLAN

SCALE 1:75

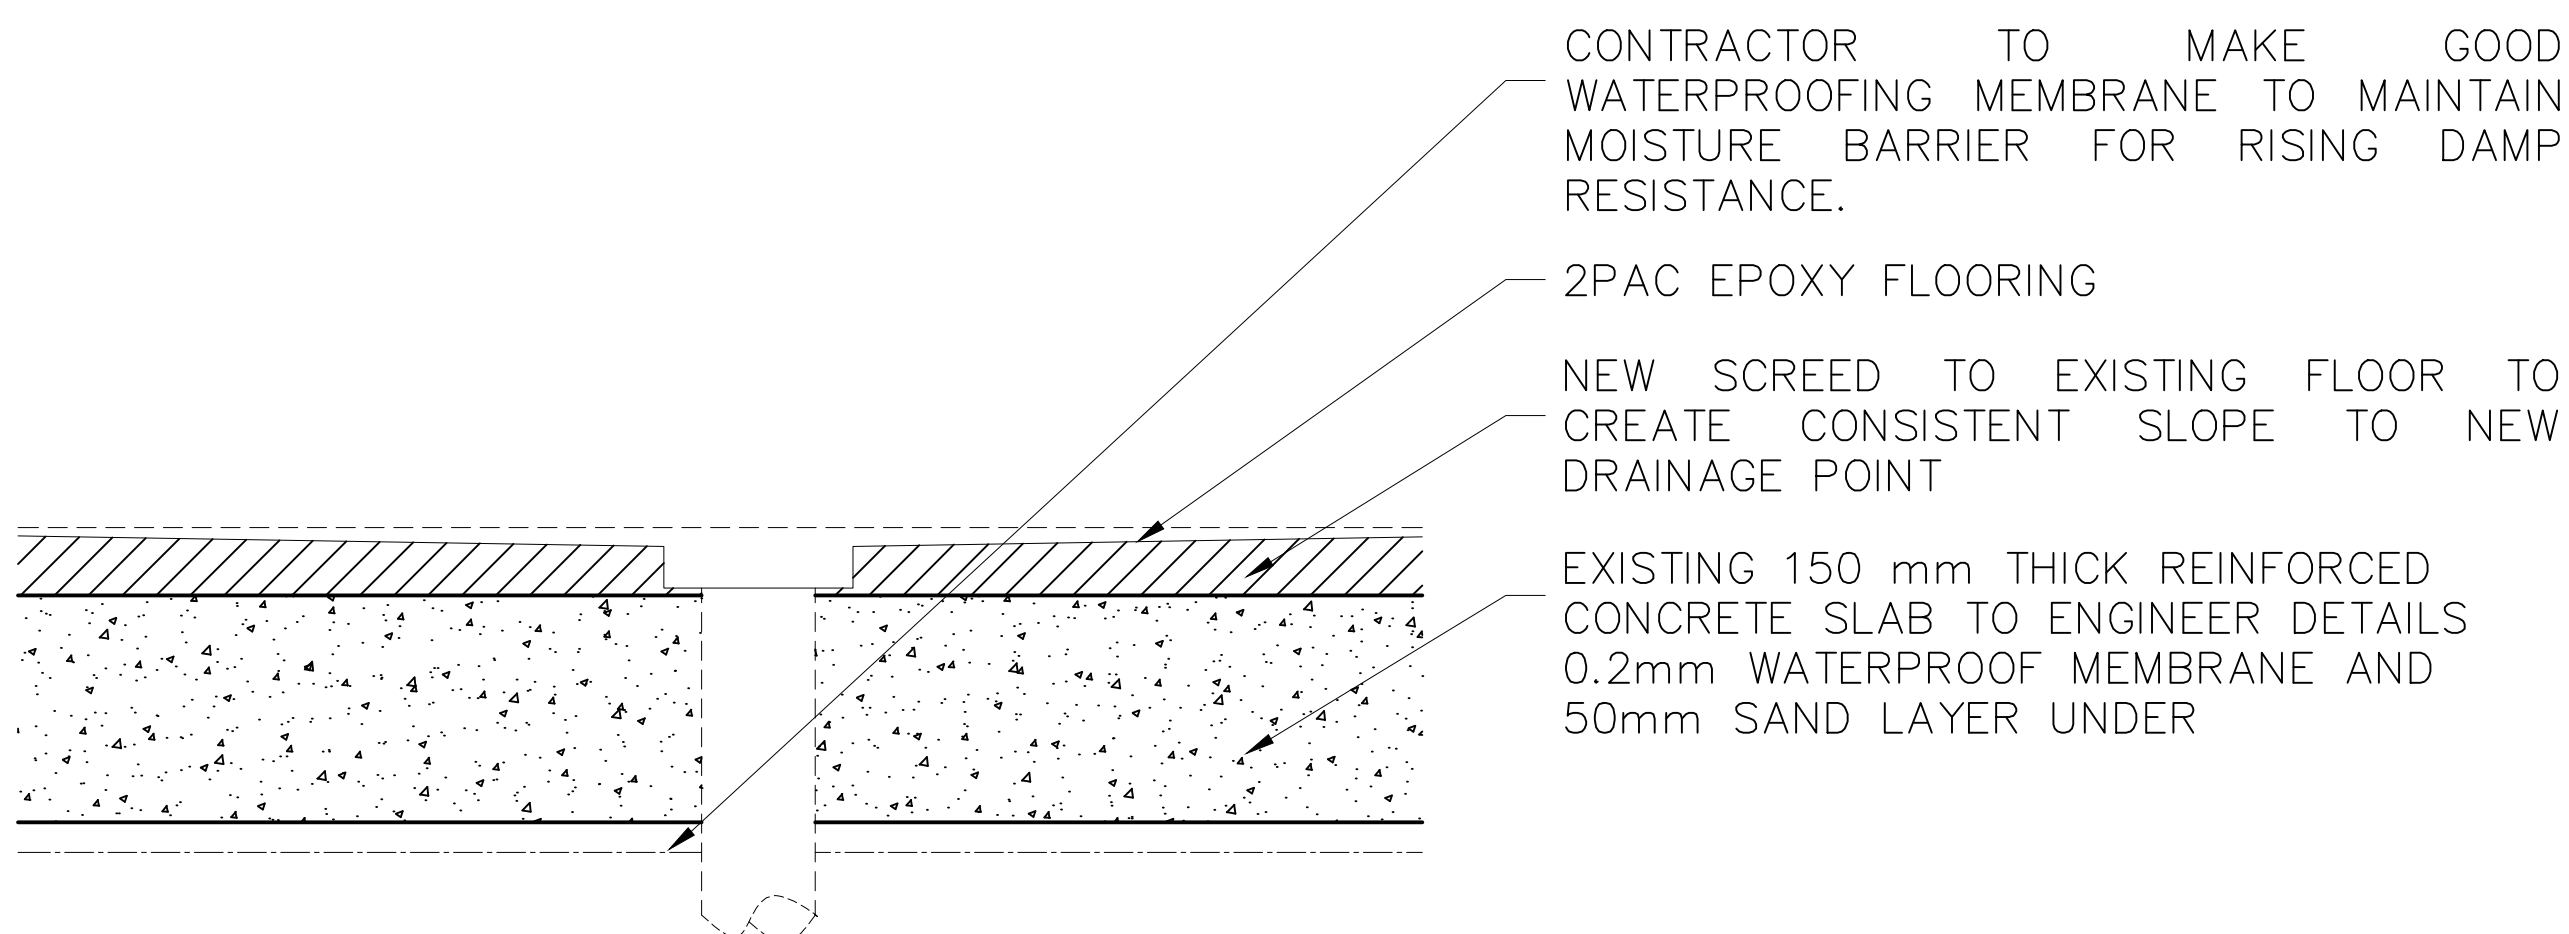

NEW DRAINAGE DETAIL

SCALE 1:20

GENERAL NOTES

1. ALL PLUMBING WORK MUST COMPLY WITH THE NATIONAL CONSTRUCTION CODE (NCC) AND AS/NZS 3500 – PLUMBING AND DRAINAGE STANDARDS.
2. INSTALLATION MUST ADHERE TO THE RELEVANT LOCAL COUNCIL REGULATIONS AND WATER AUTHORITY REQUIREMENTS.

LEGEND

MARK	DESCRIPTION
	NEW DRAINAGE POINT
	WASTE LINE

DRAWING NOTES

A	13.10.24	BW	ISSUED FOR BUILDING PERMIT / APPROVA
REV	DATE	CHKD	DESCRIPTION

WDC Williams Drafting Co

www.WilliamsDrafting.co
A.C.N. 663 469 949 Tel. +61 417 956 493
PO Box 1220 Canning Bridge, Applecross WA 6153


PROJECT
PROPOSED CATTERY
5B KELLY COURT
SPRINGVALE, VICTORIA

SHEET

PLUMBING PLAN- SHEET 4			
DRAWN	LJS	SCALE (© A1):1:75, 1:20	
DESIGNED	BW	DWG No:	REV
CHECKED	BW	WDC24-0036-A5	A

! NOTE:


ALL PLUMBING AND DRAINAGE SYSTEMS
MUST BE PRESSURE TESTED AND INSPECTED
BEFORE COVERING OR CONCEALMENT,
FOLLOWING THE GUIDELINES OF AS/NZS
3500.

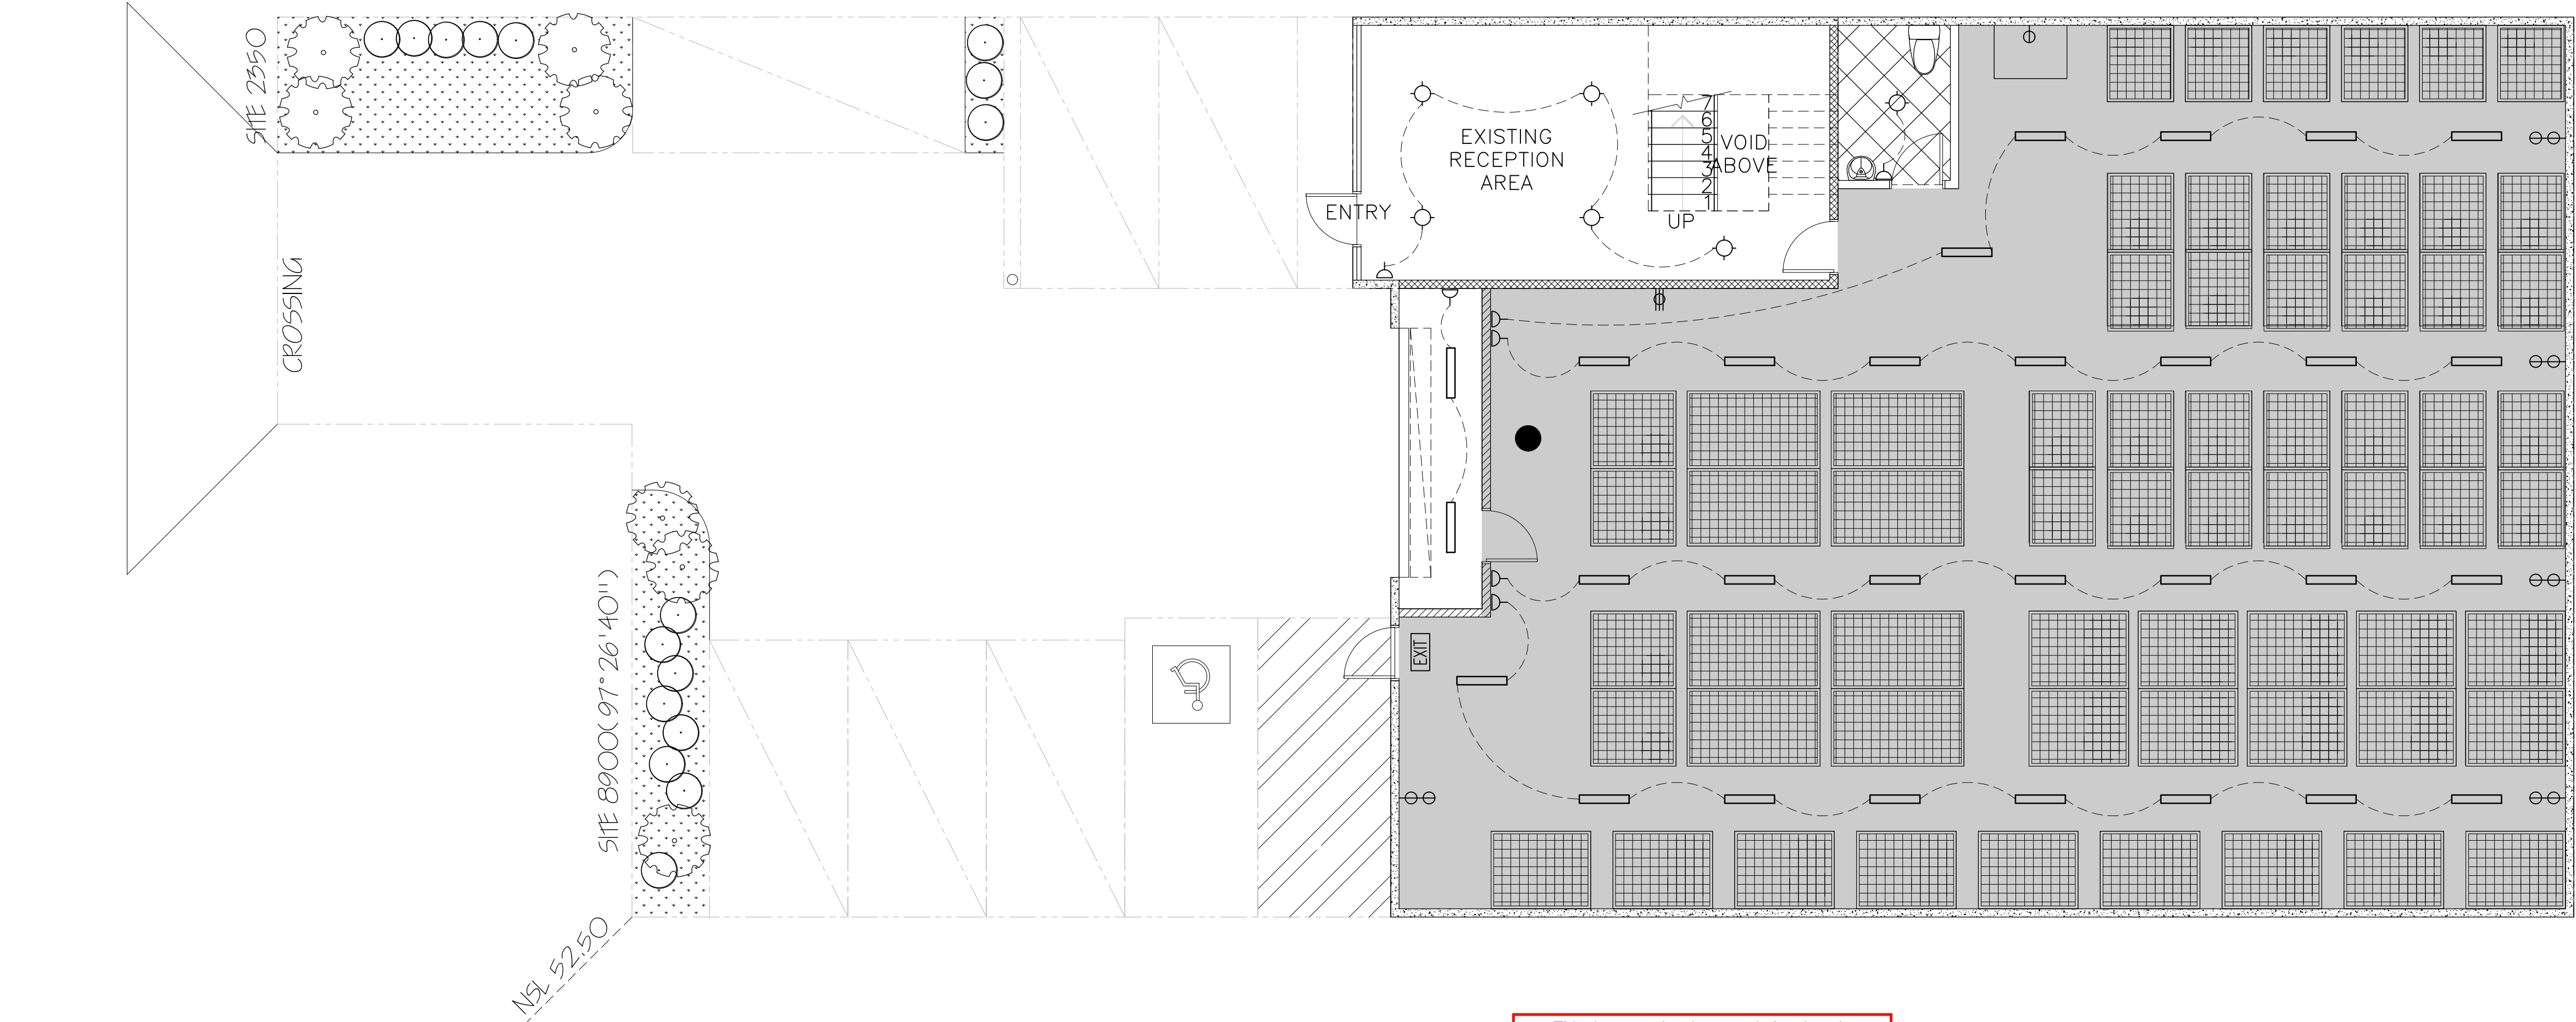

GROUND FLOOR ELECTRICAL PLAN

SCALE 1:75

This document has been copied and made available for the purpose of the planning process as set out in the Planning and Environment Act 1987. The information must not be used for any other purpose. By taking a copy of this document you acknowledge and agree that you will only use the document for the purpose specified above and that any dissemination, distribution or copying of this document is strictly prohibited.

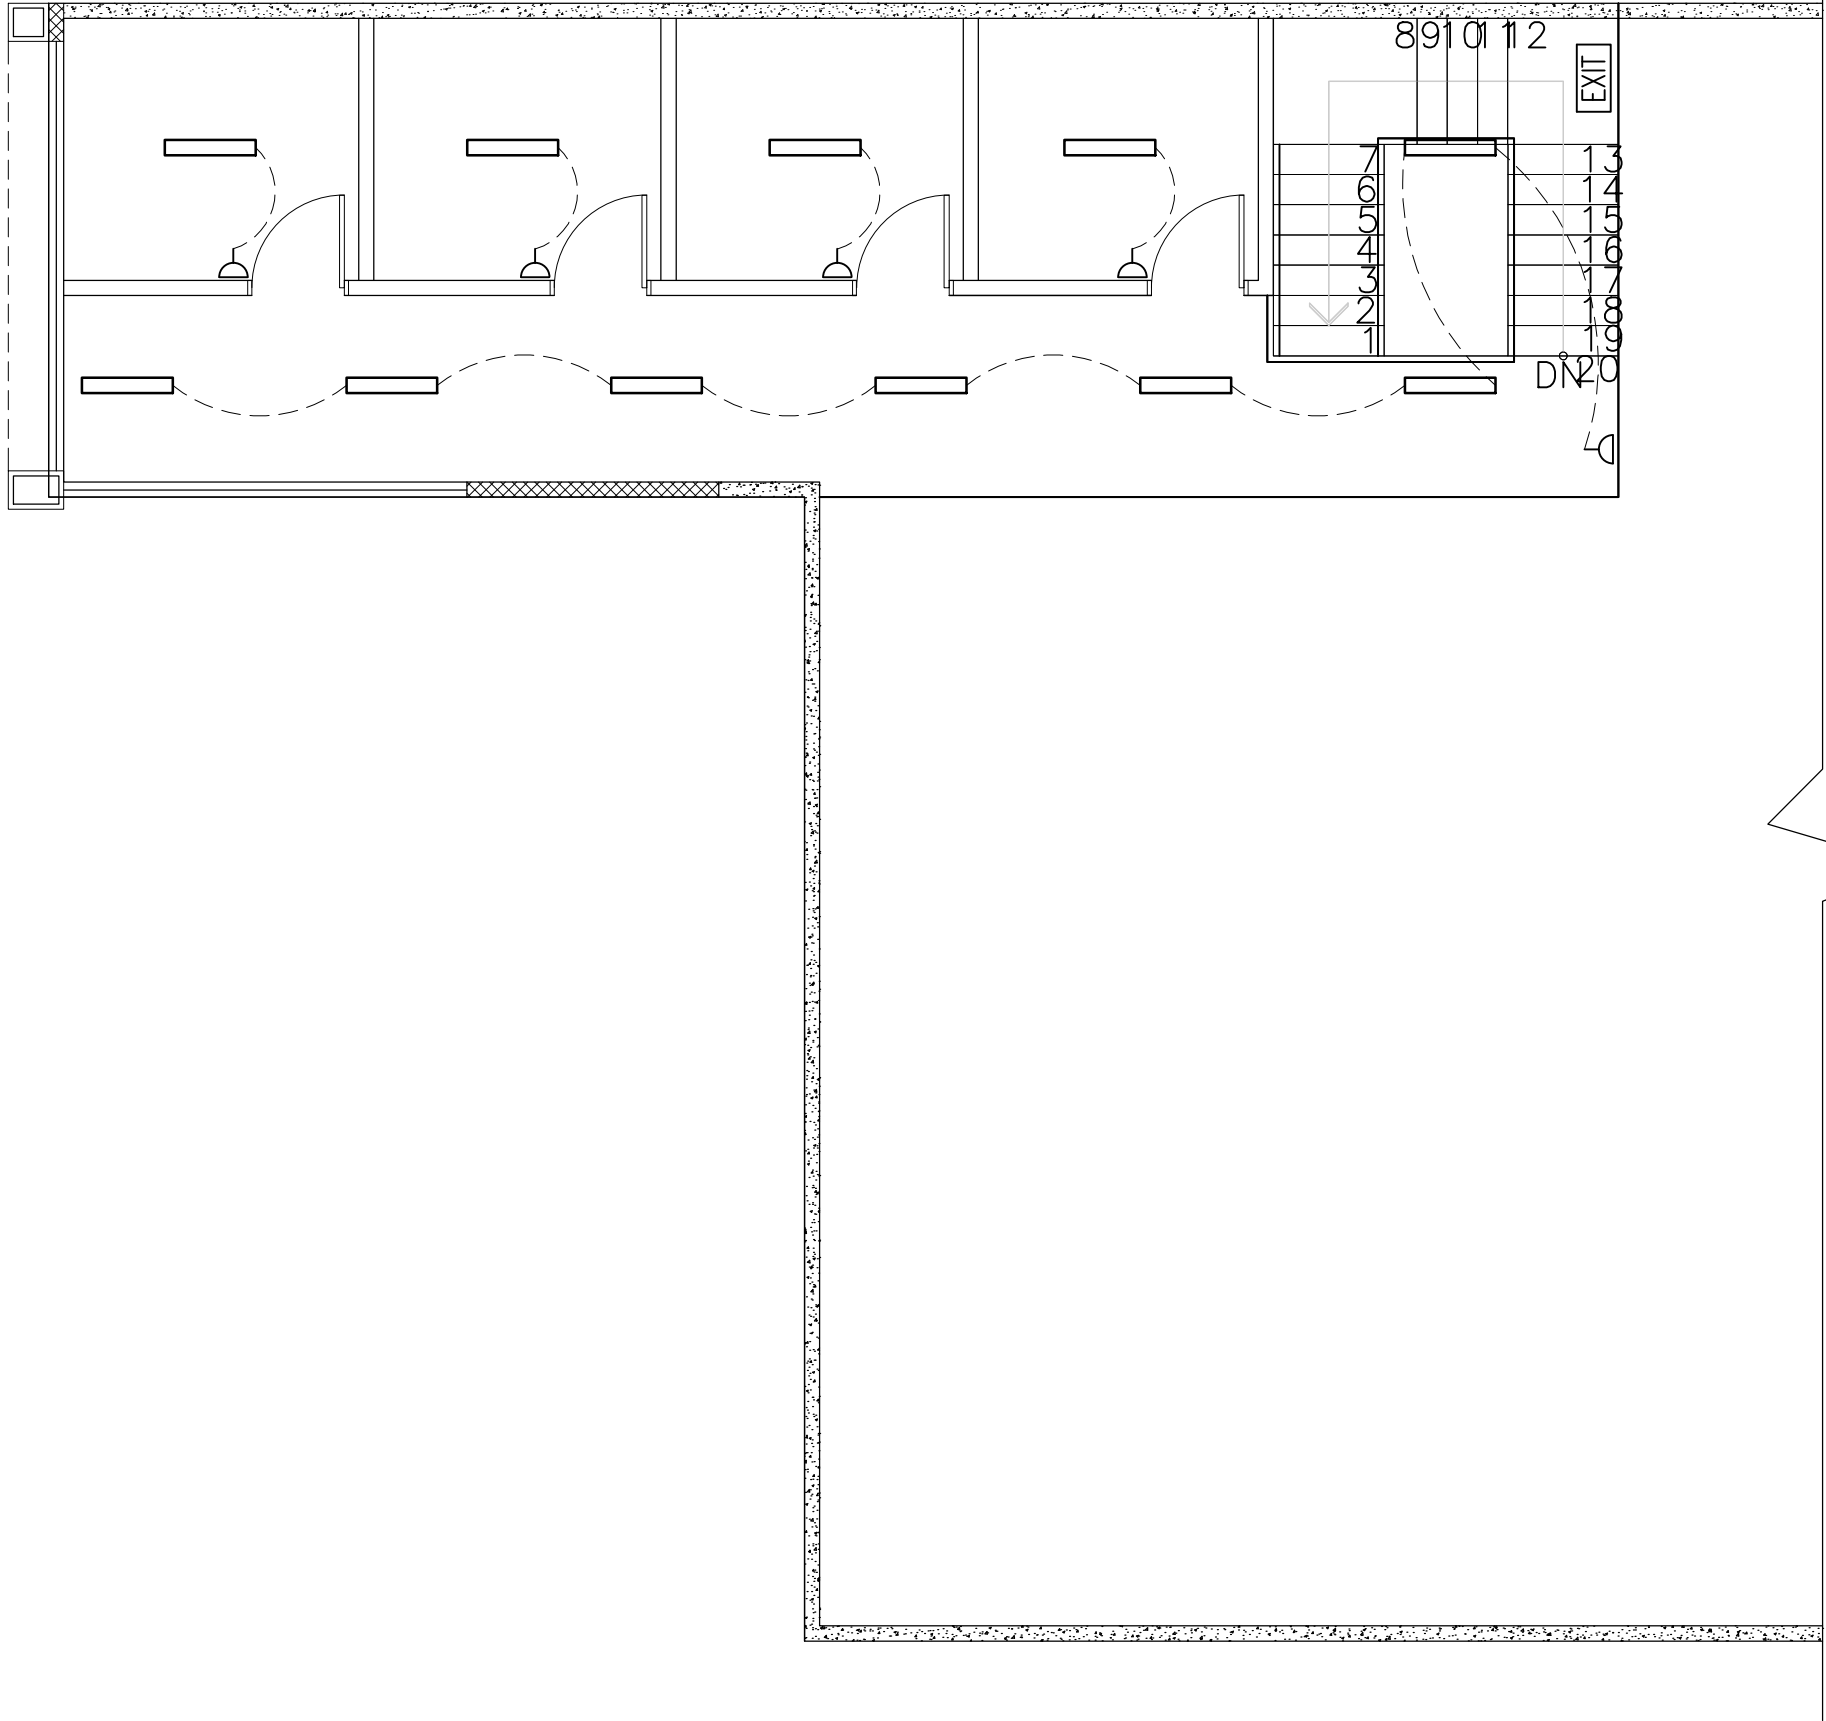

FIRST FLOOR ELECTRICAL PLAN

SCALE 1:75

! NOTE:
ELECTRICIAN TO PROVIDE ISOLATOR SWITCHES FOR ALL A/C UNITS, AMPS TBC.

BUILDER TO PROVIDE PROVISION FOR FUTURE CONNECTION TO THE NATIONAL BROADBAND NETWORK.

GENERAL NOTES	
1. THE EXISTING CONSTRUCTION, WALLS, FLOORS, COLUMNS, ETC VARY IN SIZE, DIAMETER, SPACING, PLUMB, AND SQUARE.	
2. BUILDER TO CHECK ALL DIMENSIONS AND DETAILS ON SITE BEFORE COMMENCEMENT, AND MAKE ANY NECESSARY ADJUSTMENTS TO ENSURE THAT NEW WORK FITS IN.	

LEGEND	
MARK	DESCRIPTION
[Symbol]	LED PANEL LIGHT
[Symbol]	EXISTING LIGHT FITTING
[EXIT]	EMERGENCY BULKHEAD/EXIT SIGN LUMINAIRE
[EXIT]	EMERGENCY BULKHEAD/EXIT SIGN LUMINAIRE DIRECTIONAL
[Symbol]	SINGLE PHASE SINGLE POWER POINT
[Symbol]	SINGLE PHASE DOUBLE POWER POINT
[Symbol]	OVERHUNG SINGLE PHASE 3 PIN 240V 10A (DRAWS 3 PHASE ON START UP)
[Symbol]	THREE PHASE 5 PIN POWER POINT WITH ISOLATOR
[Symbol]	THREE PHASE HARDWIRED (415V)
[Symbol]	LIGHT SWITCH

DRAWING NOTES

A	13.10.24	BW	ISSUED FOR BUILDING PERMIT / APPROVAL
REV	DATE	CHKD	DESCRIPTION

WDC Williams Drafting Co

www.WilliamsDrafting.co
A.C.N. 663 469 949 Tel +61 437 956 493
PO Box 1220 Canning Bridge, Applecross WA 6153

PROJECT
**PROPOSED CATTERY
5B KELLY COURT
SPRINGVALE, VICTORIA**

SHEET
**ELECTRICAL PLAN—
SHEET 5**

DRAWN	LJS	SCALE (© A1):1:75	REV
DESIGNED	BW	DRG No:	
CHECKED	BW	WDC24—0036—A6	A